


Water Supply wells

Upgradient Monitoring Well

Leachfields

Downgradient Monitoring Well

Item 15 Attachment 1
May 12, 2006 Meeting
Prunetree Shopping Center Map

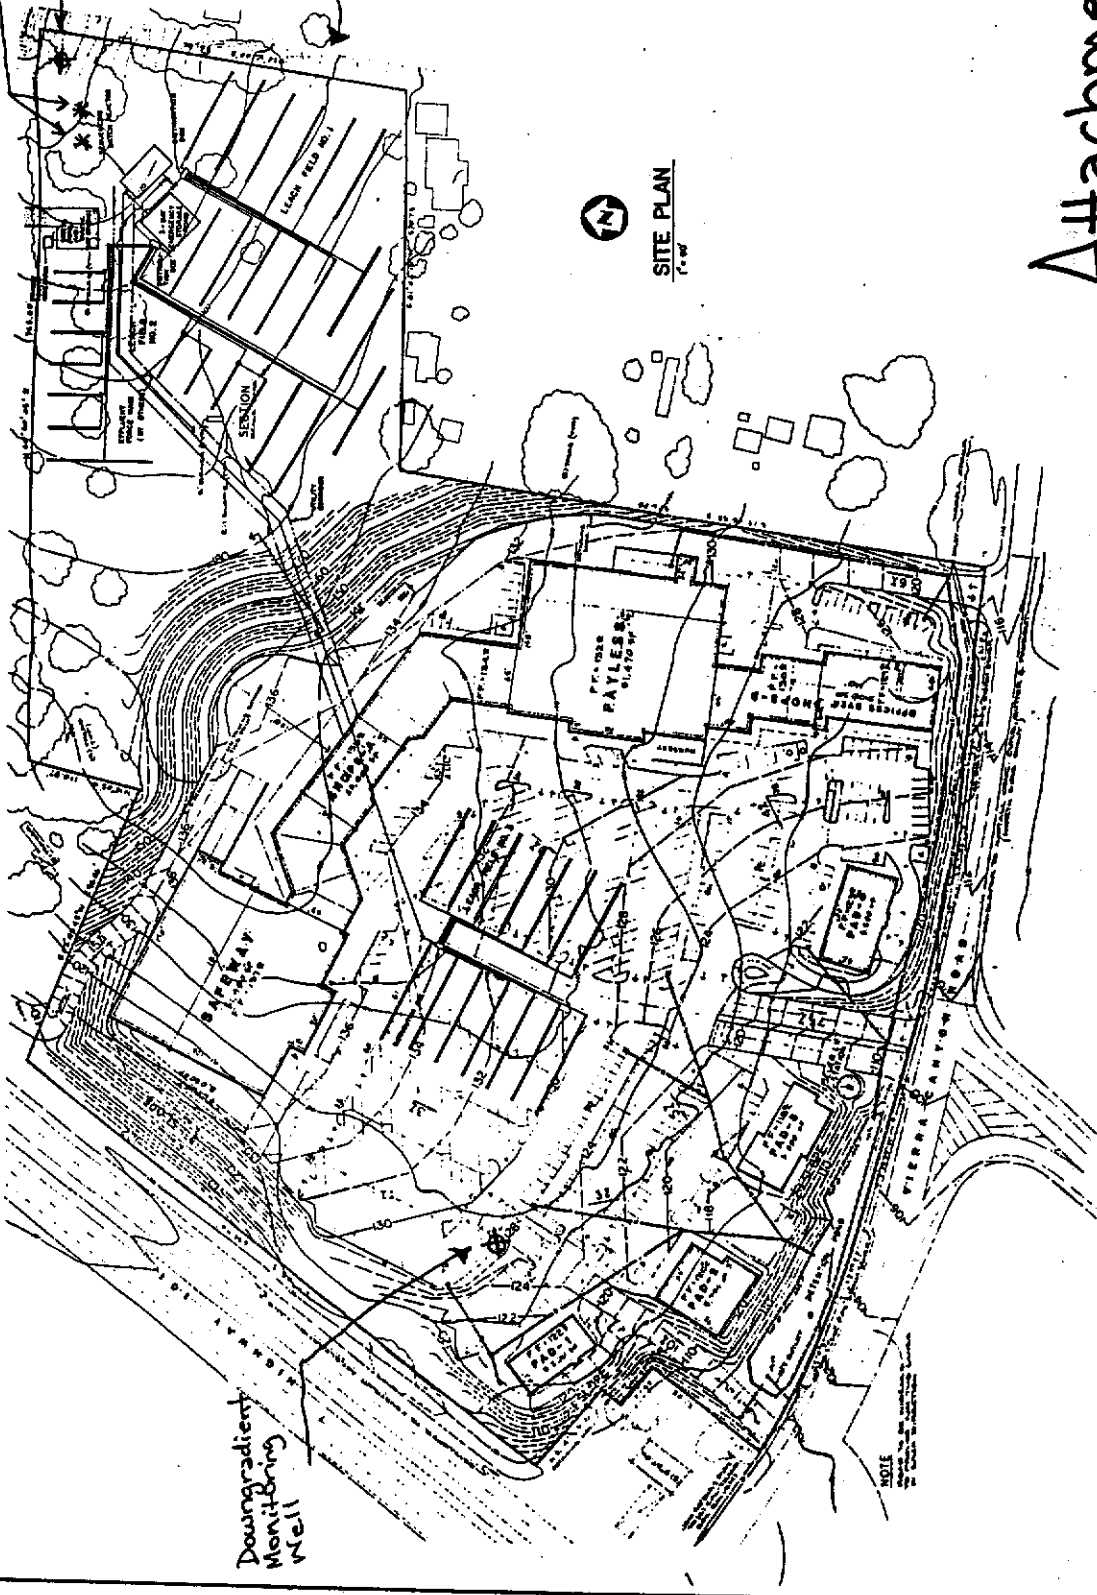

SITE PLAN

Attachment 1

DATE	
BY	
PROJECT NO.	AVC0003
DESIGNED BY	J. COOPER
DRAWN BY	J. COOPER
CHECKED BY	
APPROVED BY	
DATE	
SCALE	

ES
ENGINEERING SCIENCE
INCORPORATED
11550 WILSON AVENUE, SUITE 100
PRUNETREE, CALIFORNIA 94585
(925) 463-1155

THE PRUNETREE
OWNER 7 DEVELOPERS: DENNIS, KEITH
PRUNEDALE CALIFORNIA

THE PRUNETREE WASTEWATER TREATMENT FACILITY
PRELIMINARY SITE PLAN
DATE: 05/12/06